


NOTE ③:  
FIRE EXTINGUISHER: 4A4BC OR 4A60BC MIN, FIRE EXTINGUISHER MOUNTED 36" TO THE TOP OF THE HANDLE AFF W/ A 75' UNIMPEDED TRAVEL DISTANCE.

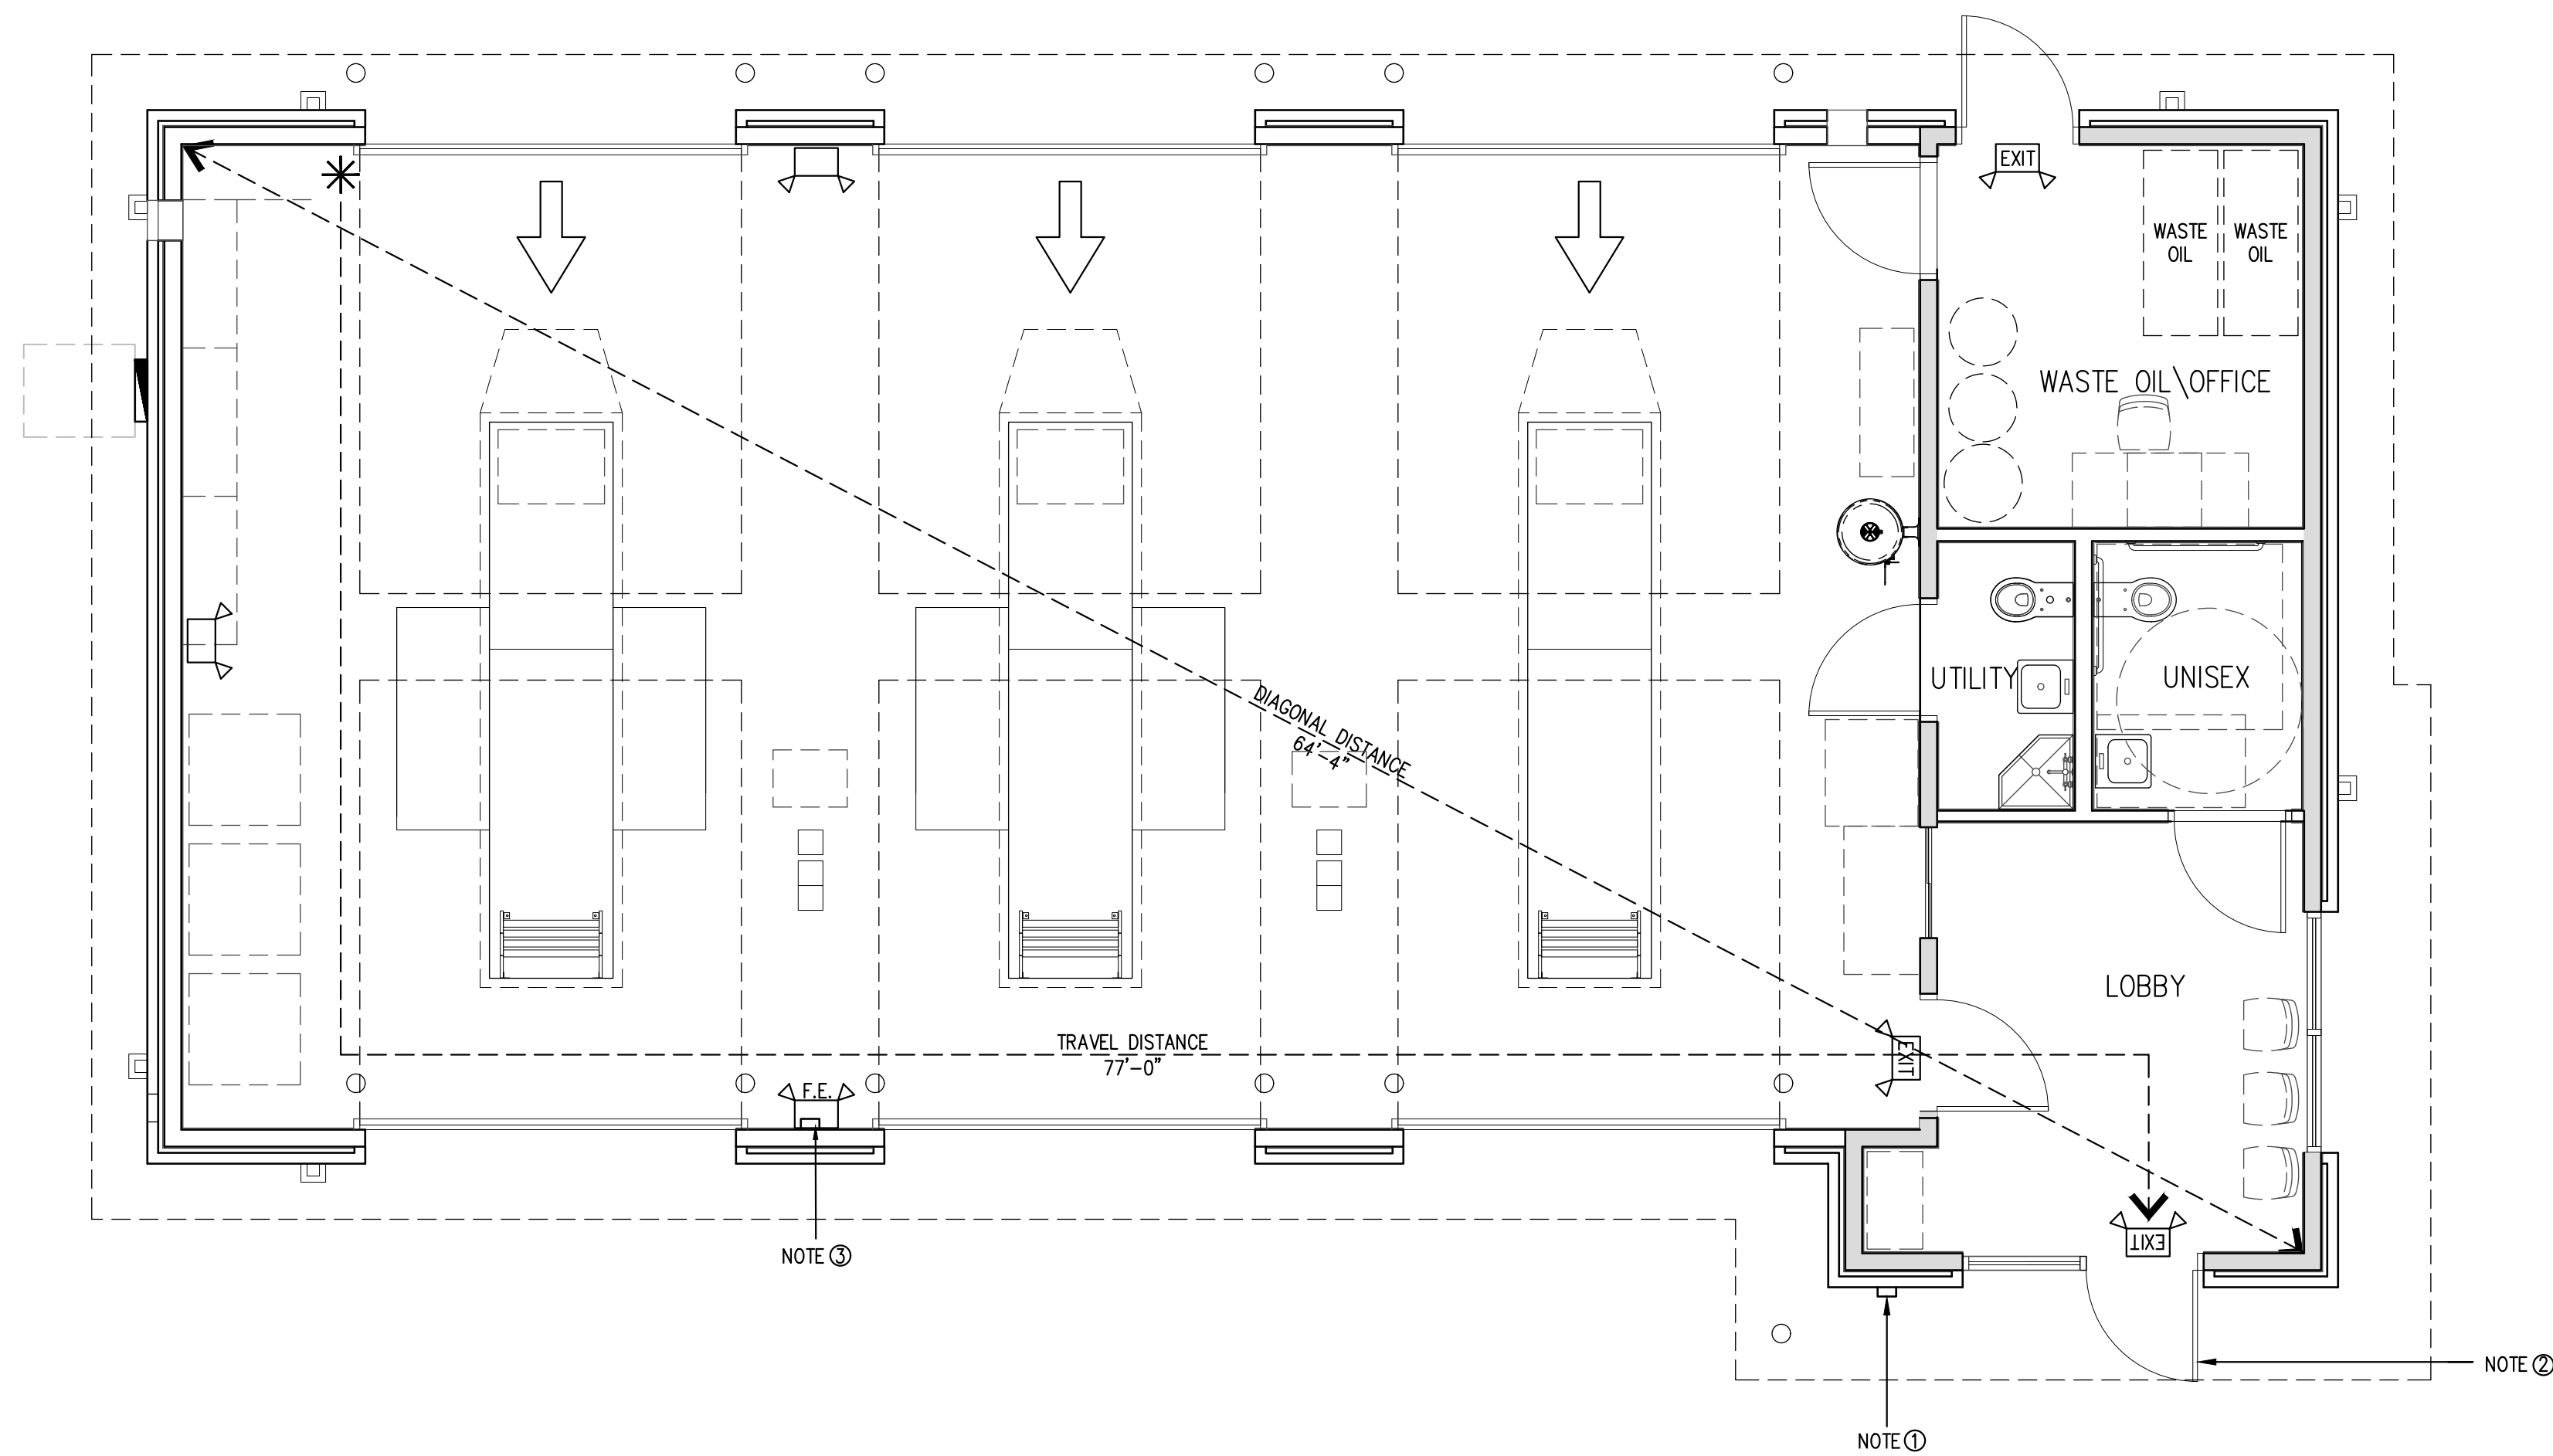

REFER TO E1.0 ELECTRICAL PLANS FOR LAYOUT  
OF EMERGENCY LIGHTING; INSTALL EMERGENCY  
LIGHTING TO BE SAME AS ELECTRICAL


OPERATIONAL NOTE:

CLASS 1 LIQUIDS ARE NOT STORED IN STRICKLAND BROTHERS BUILDINGS.

CLASS IIIB LIQUID (MOTOR OIL) IS STORED IN THE BACK ROOM AREA WHICH IS VENTILATED AS REQUIRED. SEE MECHANICAL SHEETS.

NO LIQUIDS ARE STORED IN THE LUBE TRENCHES.

VEHICLES ARE OPERATED ONLY FOR THE DURATION OF MOVING THEM INTO & OUT OF THE BUILDING.

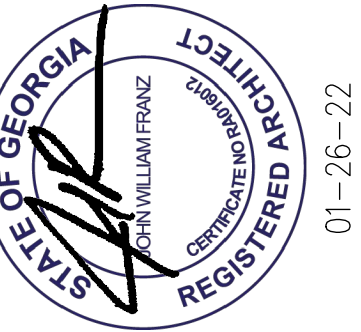The logo for John Franz architect features a stylized 'F' icon to the left of the text 'JOHN FRANZ' in a large, bold, sans-serif font, with 'architect' in a smaller, lowercase font below it.

(817) 737-9922

4055 International Plaza Suite 100  
Fort Worth, Texas 76109

**STRICKLAND BROTHERS**  
TBD HWY 53  
DAWSONVILLE, GA 30534

**Revisions:**

File Name: 22047 A0.5  
Project No: 22047  
Date: 01/26/22  
Drawn By:  
Checked By: TI

SHEET

**A0.5**

LIFE SAFETY PLAN